




REV.	DATE	REVISION
1	12/16/21	FOR BUILDING PERMIT
NO.	DATE	ISSUE NOTE
Project #	Phase	Plot date
211025-1	DD	12/17/21

Sheet Title

SECOND FLOOR PLANS

Sheet No.

A1.1


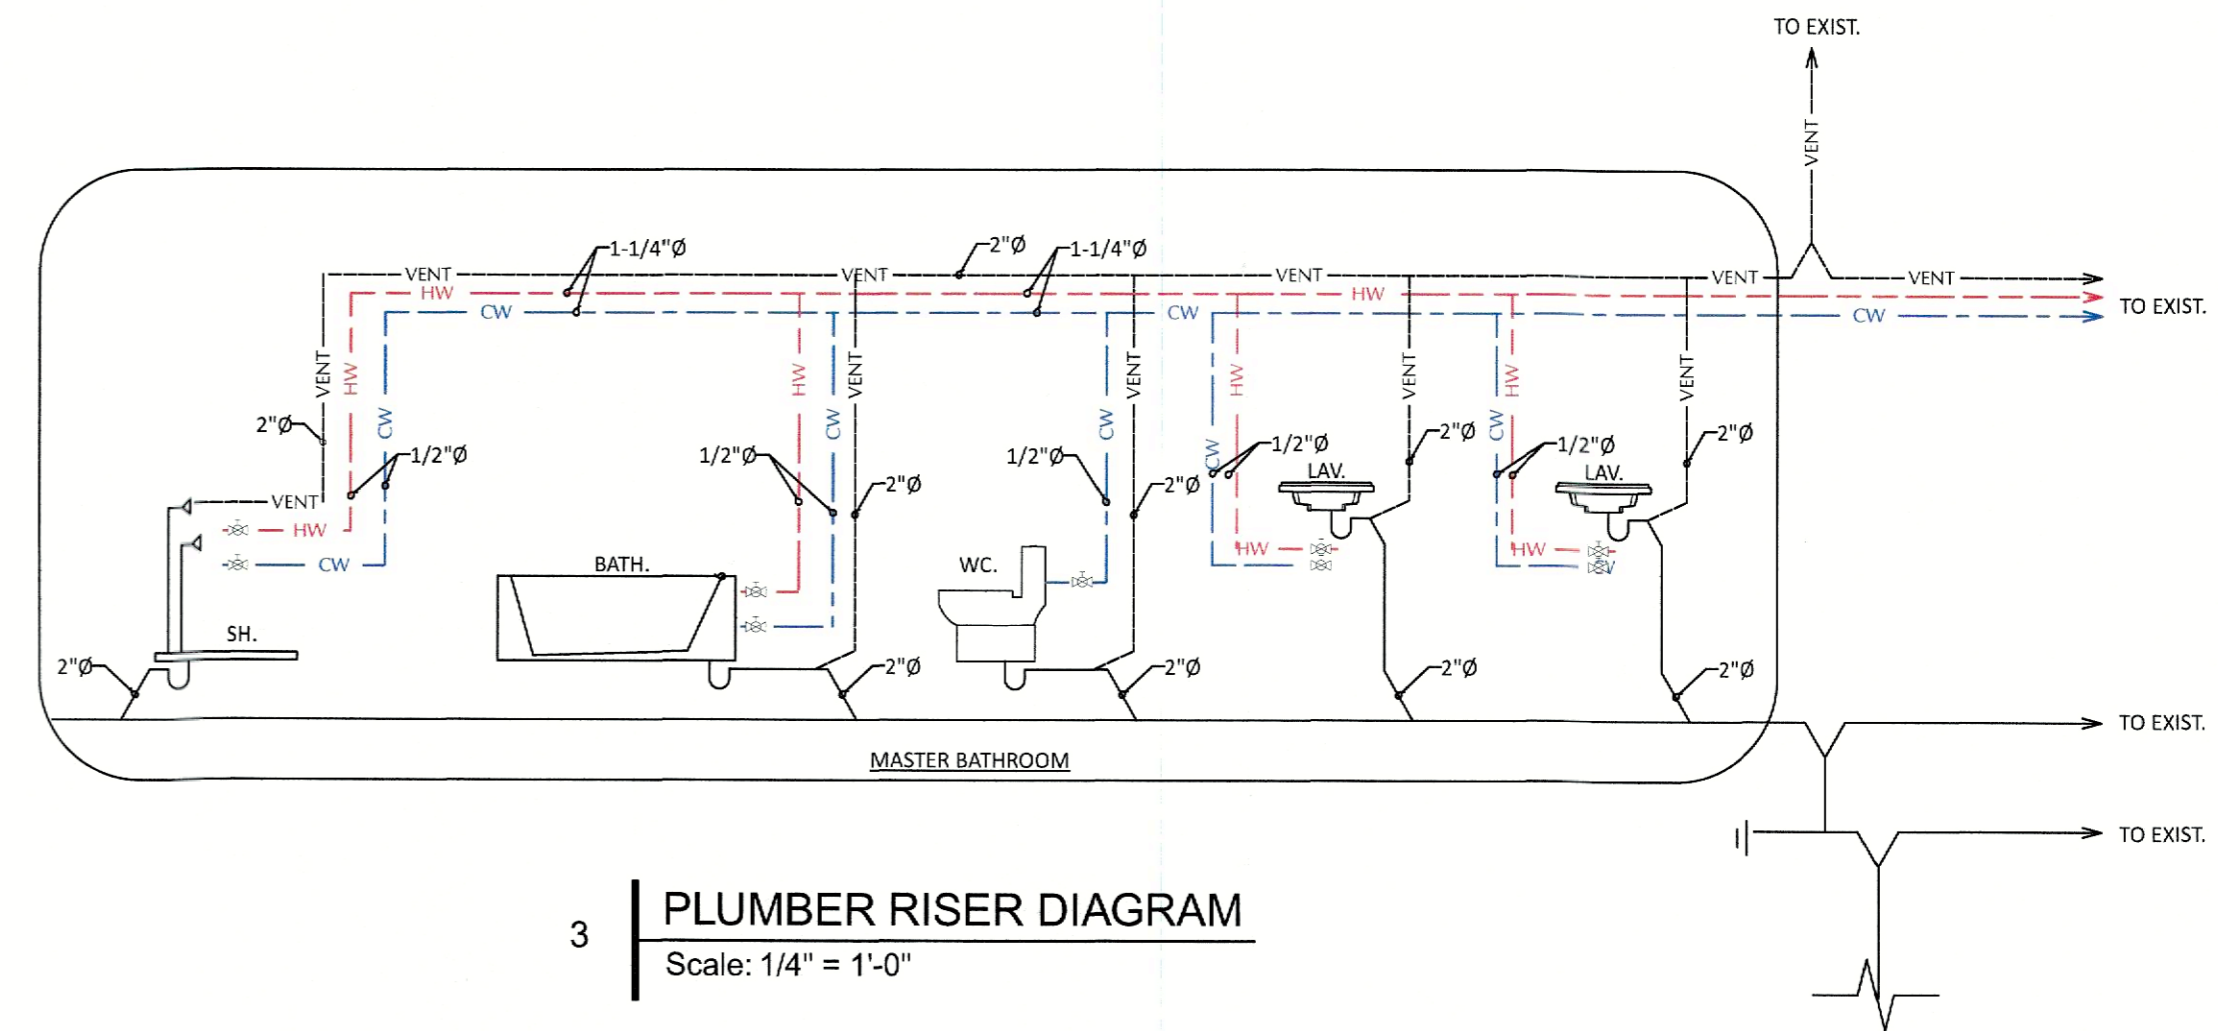


3 PLUMBER RISER DIAGRAM
Scale: 1/4" = 1'-0"



SECOND FLOOR PLAN NOTES

- 12" ROOF OVERHANG
- CHASE FOR BOILER FLUE
- 5'-0" KNEE WALL

Pipe material	Uniform Plumbing Code	International Residential Code	Minimum size
ABS/PC	1/2" to 4"	1/2" to 4"	1/2"
Cast iron	1/2" to 4"	1/2" to 4"	1/2"
Copper tubing	1/2" to 4"	1/2" to 4"	1/2"
CPVC	1/2" to 4"	1/2" to 4"	1/2"
PEX	1/2" to 4"	1/2" to 4"	1/2"
Thermostatic or heat pipe	1/2" to 4"	1/2" to 4"	1/2"

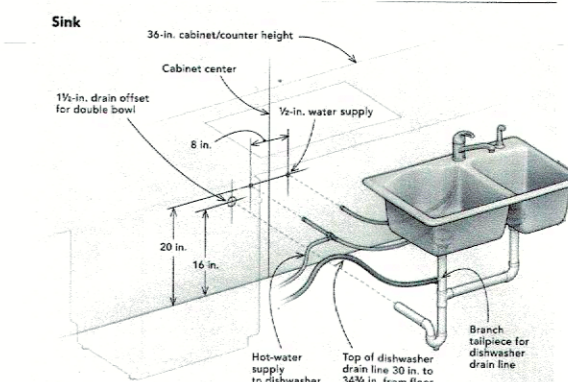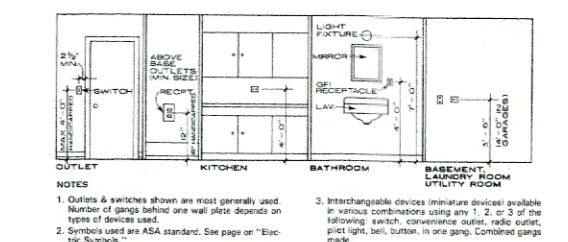

Minimum trap size (in inches)	Trap	Drain	Minimum trap size (in inches)
1/2"	1/2"	1/2"	1/2"
3/4"	3/4"	3/4"	3/4"
1"	1"	1"	1"
1 1/2"	1 1/2"	1 1/2"	1 1/2"
2"	2"	2"	2"

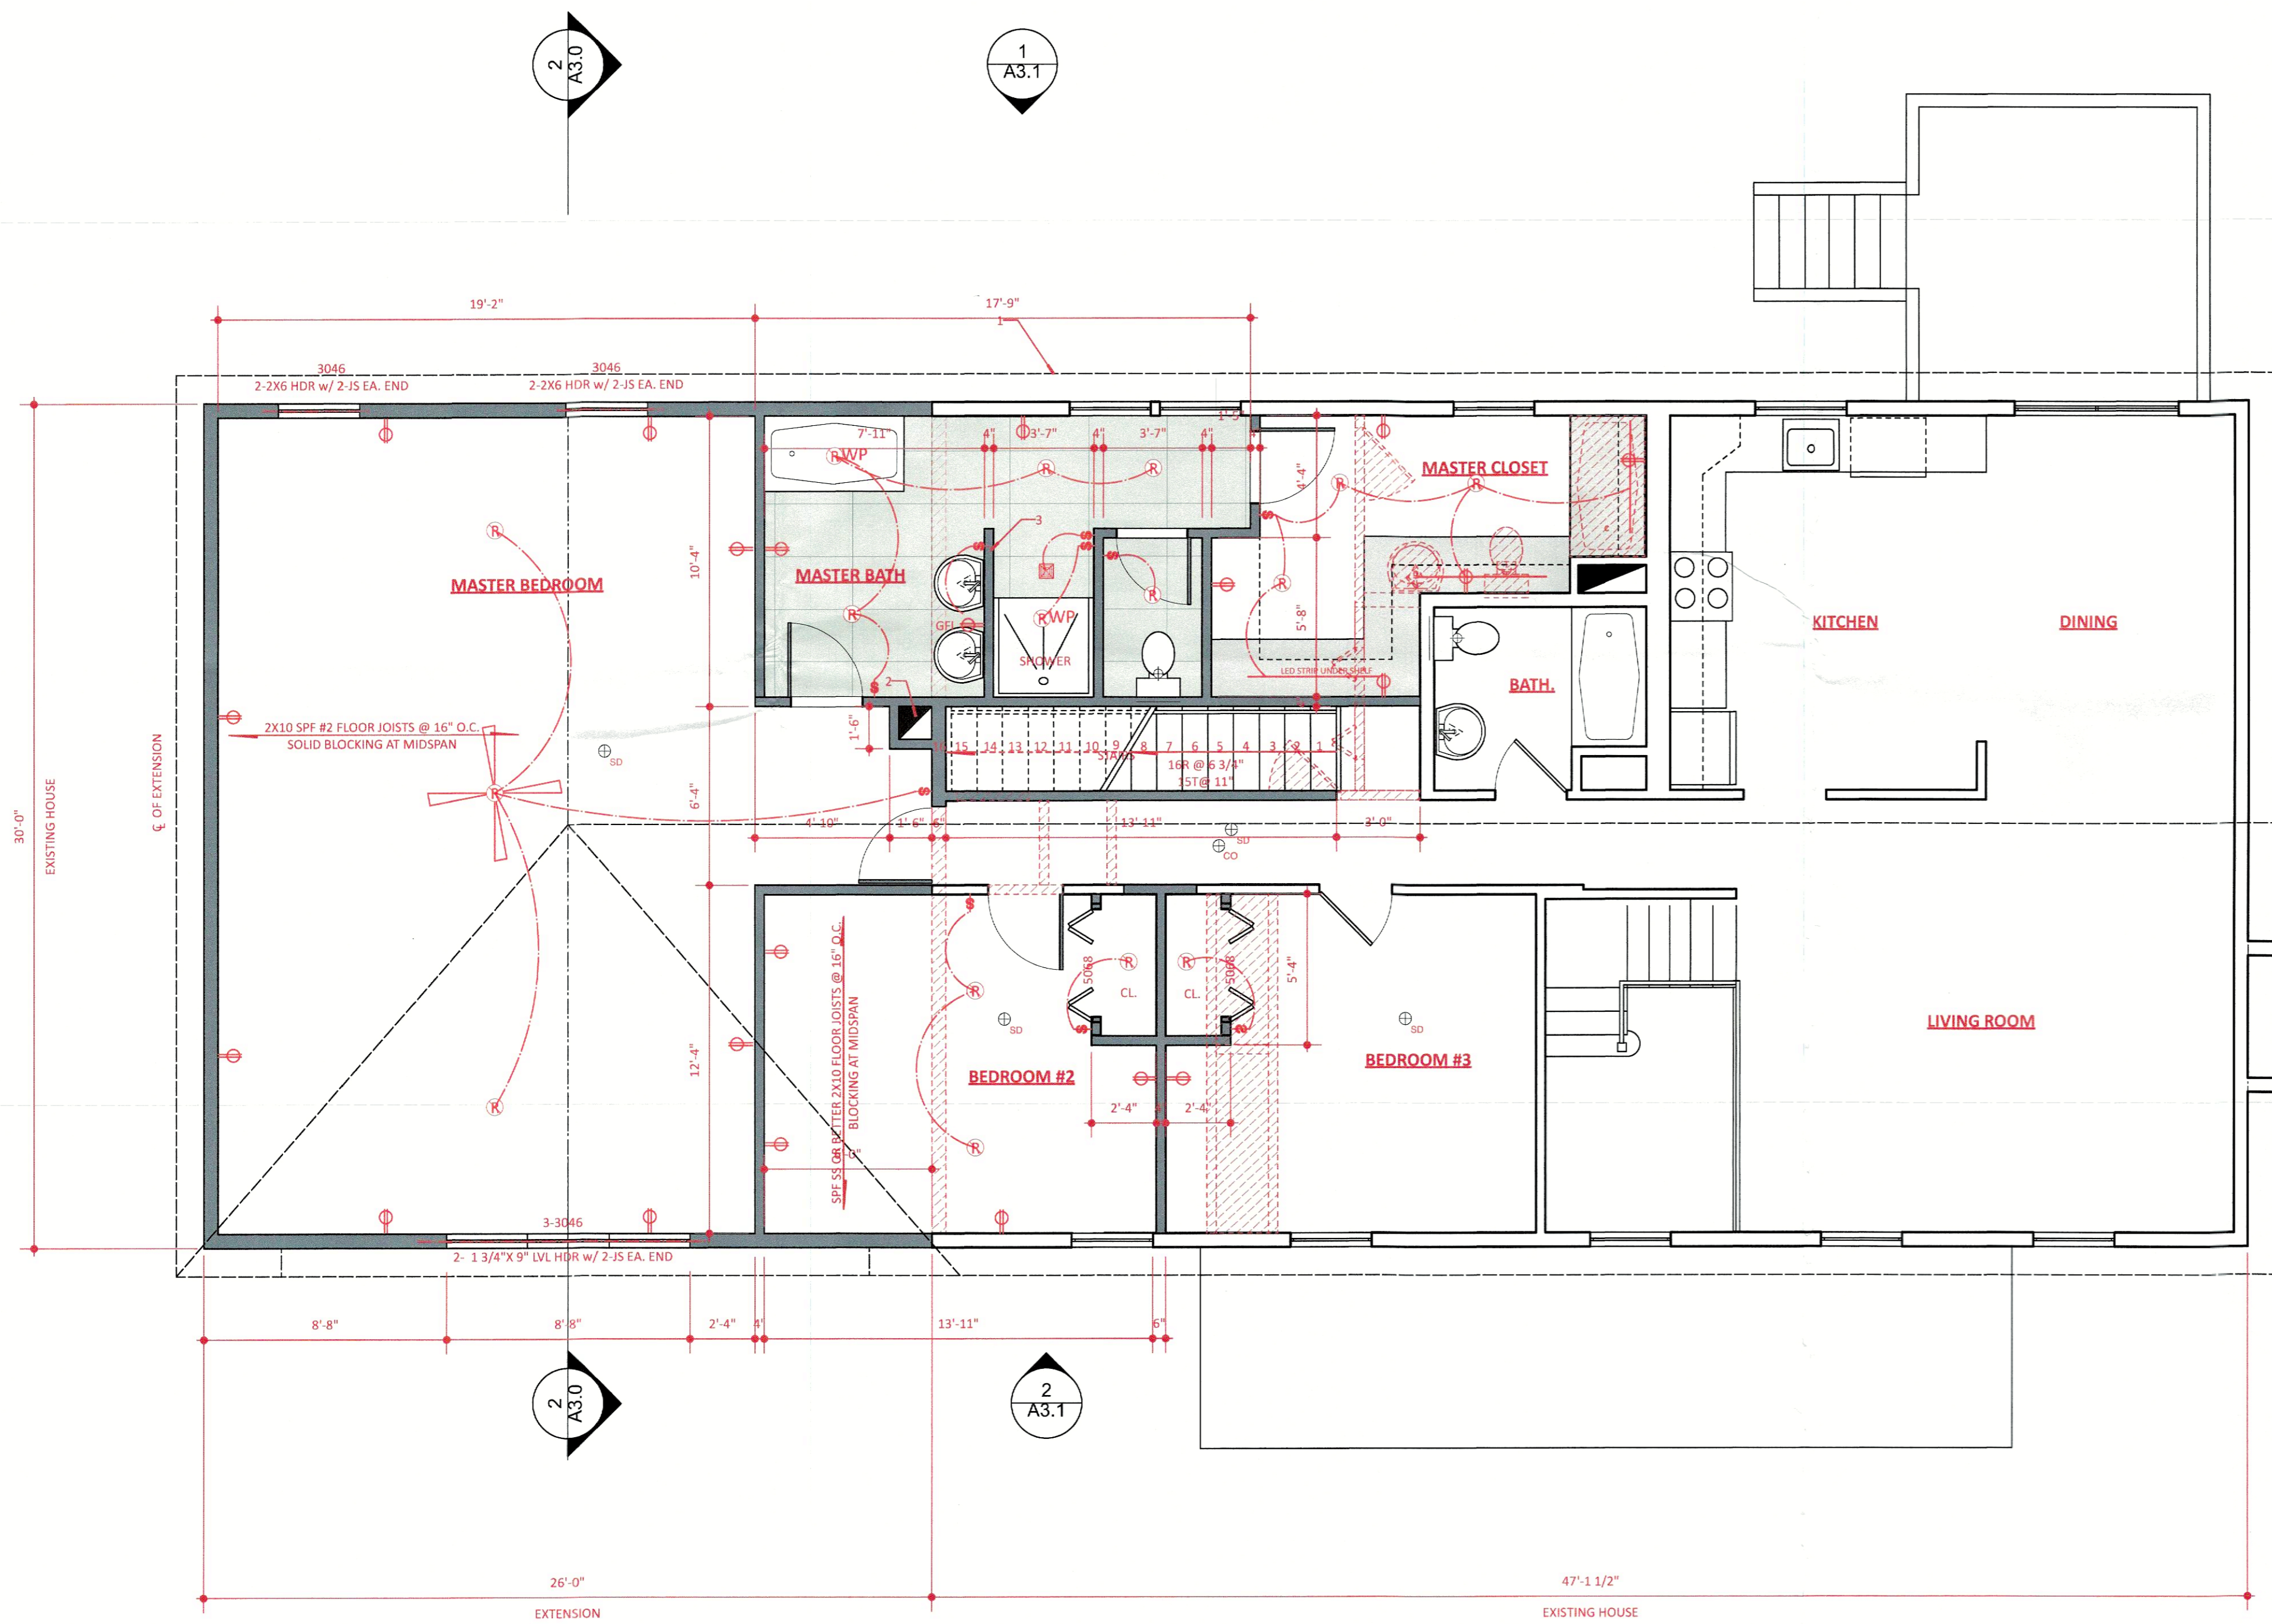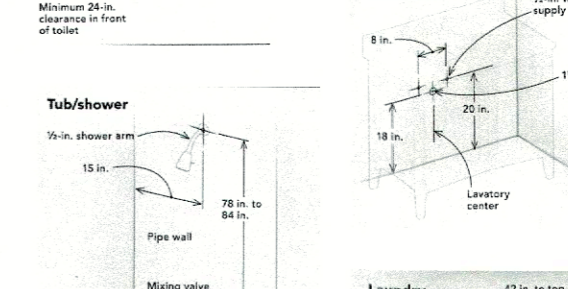

2 FIRST FLOOR PLAN
Scale: 1/4" = 1'-0"

FOR BUILDING PERMIT ONLY